

ME 24-257-0102/174

WARNING:

THE CONTRACTOR SHALL BE RESPONSIBLE FOR CALLING FOR LOCATIONS OF ALL EXISTING UTILITIES. THEY SHALL COOPERATE WITH ALL UTILITY COMPANIES IN MAINTAINING THEIR SERVICE AND/OR RELOCATION OF LINES.

THE CONTRACTOR SHALL CONTACT GOPHER STATE ONE CALL AT 651-454-0002 AT LEAST 48 HOURS IN ADVANCE FOR THE LOCATIONS OF ALL UNDERGROUND WIRES, CABLES, CONDUITS, PIPES, MANHOLES, VALVES OR OTHER BURIED STRUCTURES BEFORE DIGGING. THE CONTRACTOR SHALL REPAIR OR REPLACE THE ABOVE WHEN DAMAGED DURING CONSTRUCTION AT NO COST TO THE OWNER.




CALL BEFORE YOU DIG!

Gopher State One Call

TWIN CITY AREA: 651-454-0002
TOLL FREE: 1-800-252-1166

BENCHMARK

TOP NUT OF FIRE HYDRANT 370 FEET SOUTH OF THE INTERSECTION OF UNIVERSITY AVENUE AND SNELLING AVENUE ON THE EAST SIDE OF SNELLING
TNH ELEVATION = 228.15
ELEVATIONS SHOWN ARE BASED ON CITY OF ST. PAUL DATUM.
CONVERSION FACTOR TO 1929 NGVD, ADD 694.10.

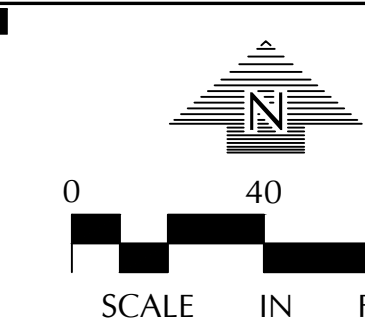

SITE LEGEND

- CONCRETE SURFACE
- GREEN/OPEN SPACE
- BITUMINOUS PAVEMENT
- LIMITS OF CONSTRUCTION
- SPECIALTY PAVEMENT


pruce
Tree
Ave.

Shields
Ave.

Snelling Ave.

Pascal St. N.

St. Anthony Avenue

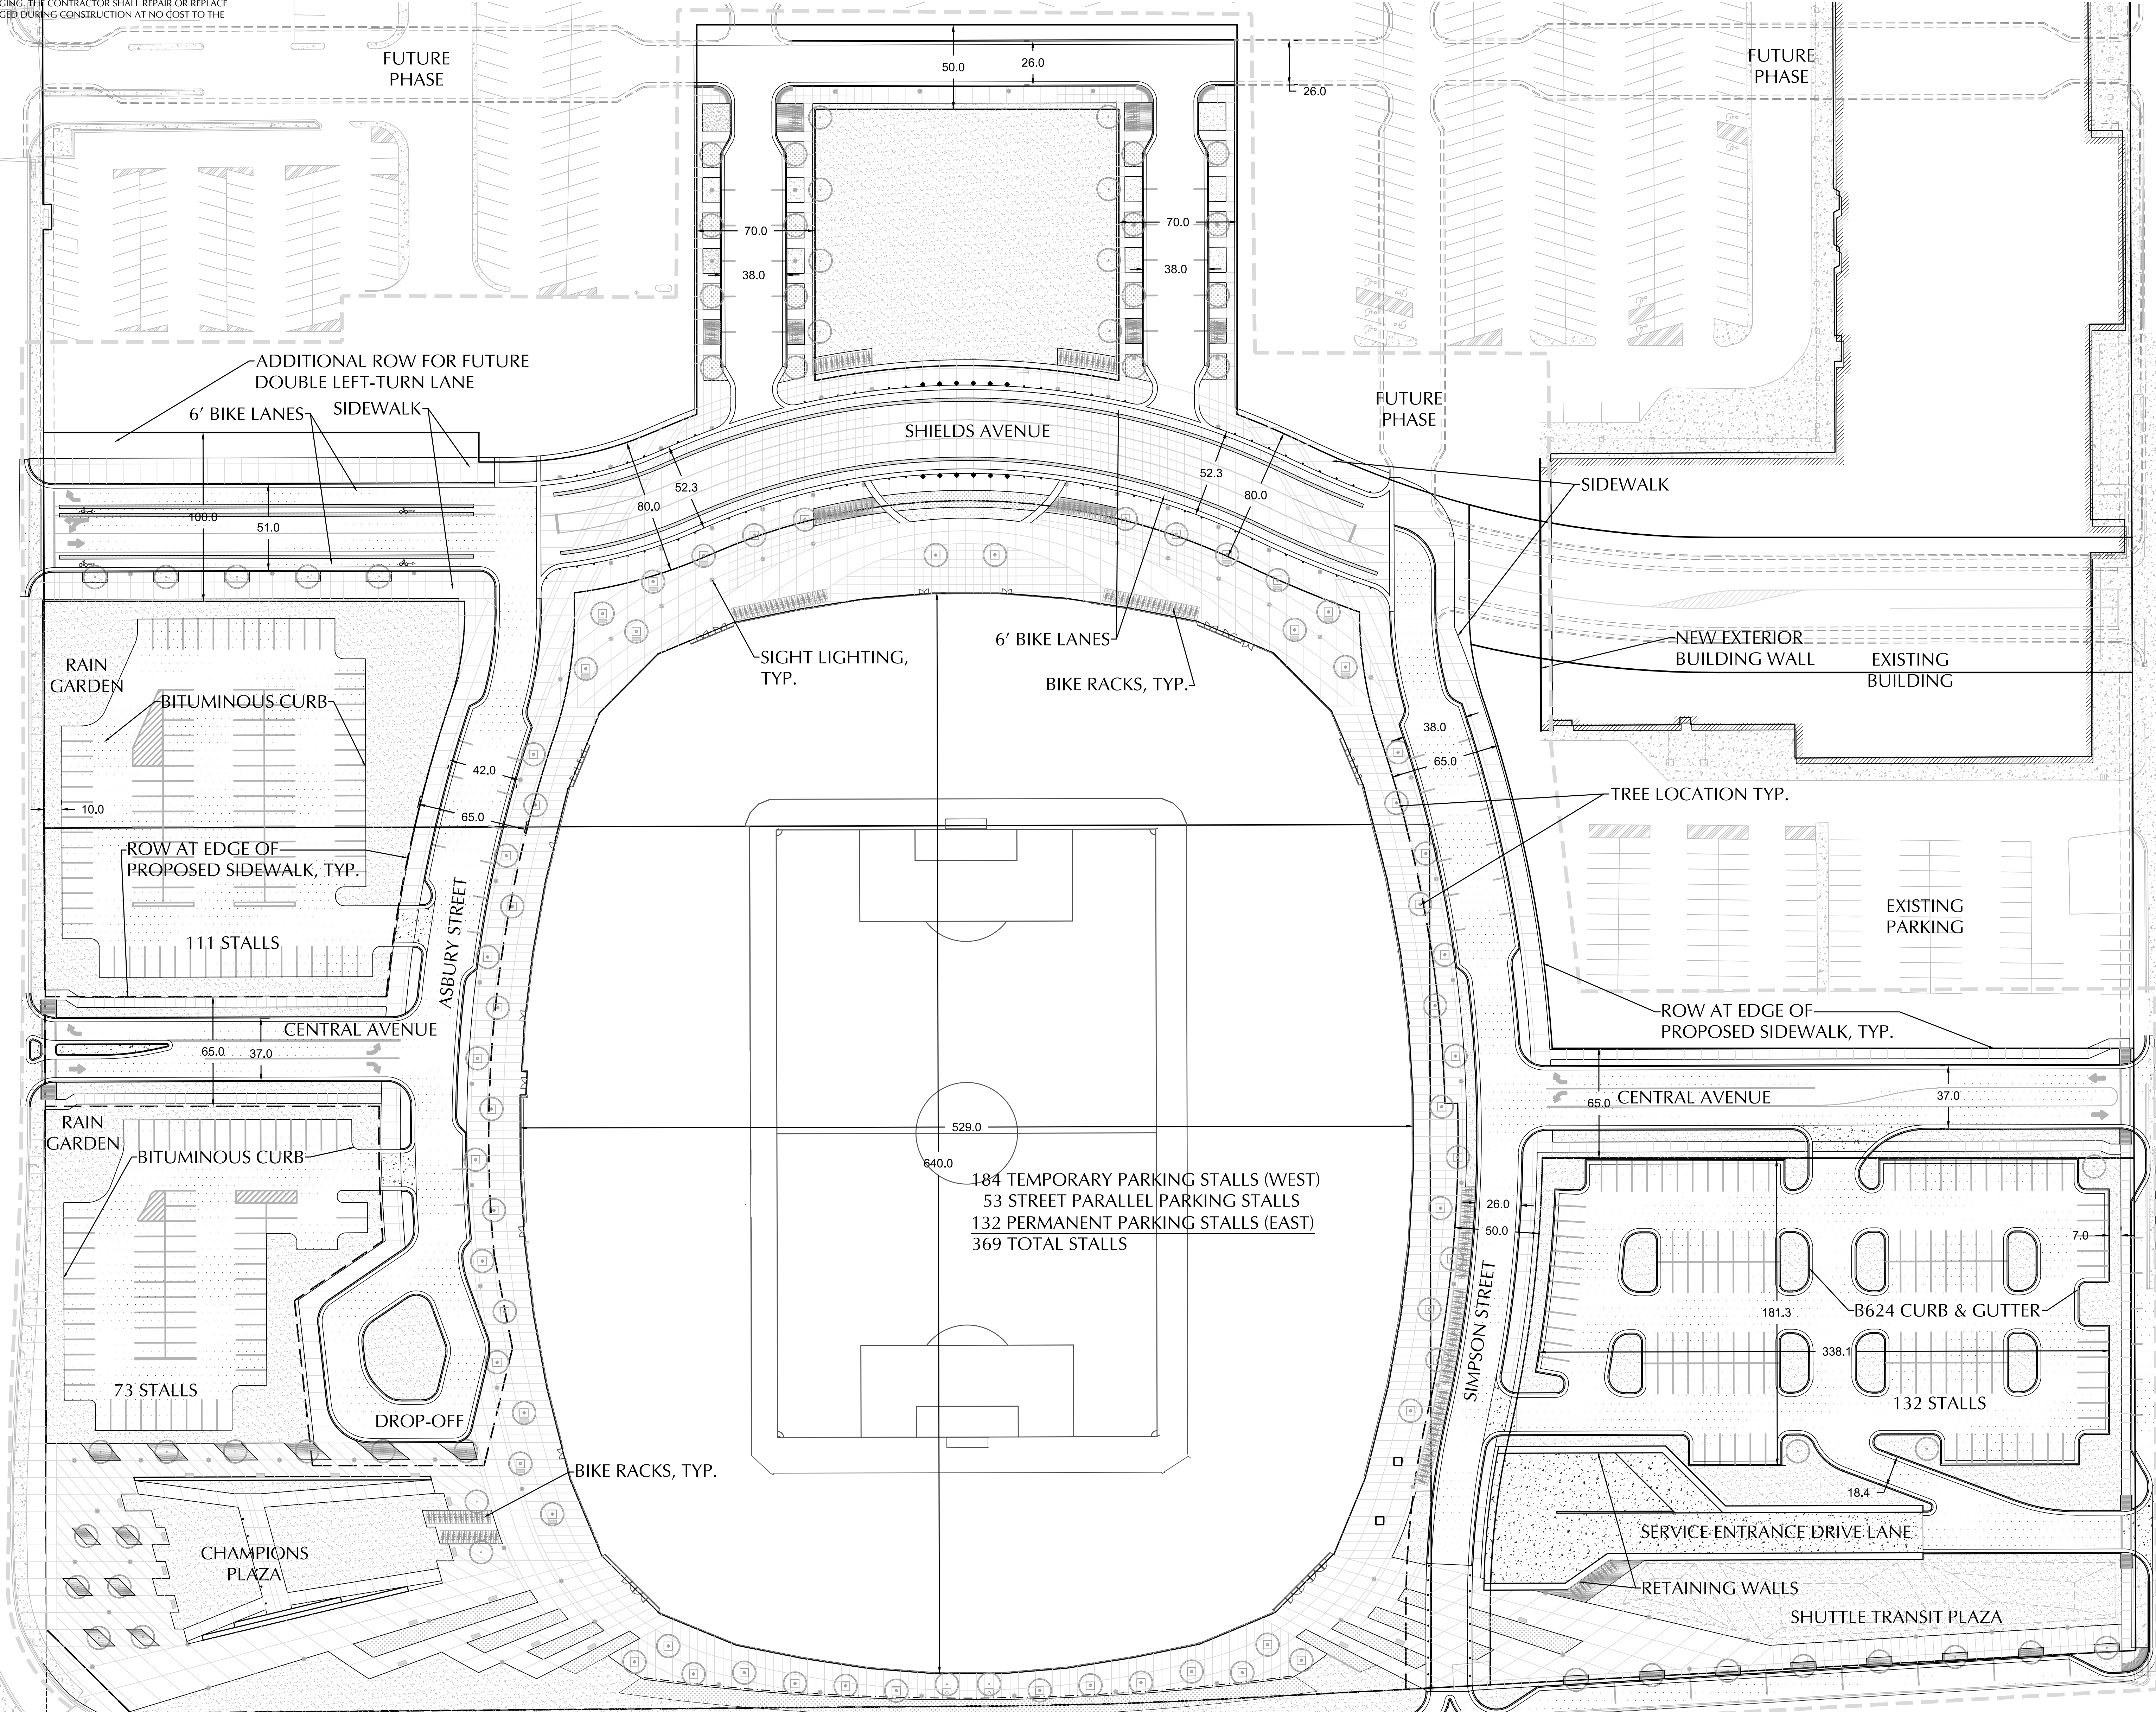

POPULOUS

POPULOUS
Architecture, Planning,
Interior Programming
4800 Main Street, Suite 300
Kansas City, Missouri 64112
816-701-2100

STRUCTURAL ENGINEER
WALTER P. MOORE
3200 MAIN STREET, TENTH FLOOR
KANSAS CITY, MO 64105
816-701-2100

MERFP ENGINEER
ME ENGINEERS
10055 W 43RD AVENUE
WHEAT RIDGE, COLORADO 80033
303-421-6655

AUDIOVISUAL
WJWW, INC.
4801 SPRING VALLEY RD. STE #113
DALLAS, TX 75244
972-966-7330

CIVIL ENGINEER
LOUCKS, INC.
7200 HEMLOCK LANE, SUITE 300
MAPLE GROVE, MN 55369
763-424-5505

LIFE SAFETY
HOWE ENGINEERS, INC.
101 LONGWATER CIRCLE, SUITE 203
NORWELL, MA 02061
781-878-3500

FOOD SERVICE
320 CONSULTANTS, INC.
13 WINDING BRANCH RD
HAWTHORN WOODS, IL 60047
224-717-1555

LOUCKS

LOUCKS
PLANNING
CIVIL ENGINEERING
LAND SURVEYING
LANDSCAPE ARCHITECTURE
ENVIRONMENTAL

7200 Hemlock Lane, Suite 300
Maple Grove, MN 55369
763.424.5505
www.loucksinc.com

MINNESOTA MLS STADIUM
SAINT PAUL, MINNESOTA

FOR REFERENCE ONLY - NOT FOR CONSTRUCTION

RECONCILED SCHEMATIC DESIGN JULY 22, 2016

REVISIONS		
NO.	DATE	DESCRIPTION
1	7-1-16	PRELIMINARY CITY SUBMITTAL
2	7-22-16	RECONCILED SCHEMATIC DESIGN

I hereby certify that this plan, specification or report was prepared by me or under my direct supervision and that I am a duly Licensed Professional Engineer under the laws of the State of Minnesota.

Jeffrey A. Shogren - PE
License No. 19624
Date 07-22-16
Loecks Project No. 16028A
Project Lead JAS
Drawn By TRG
Checked By JAS
Review Date 07-22-16

PROJECT NO. 16028A
ISSUED DATE 07/22/16
ISSUED BY LOUCKS

OVERALL SITE PLAN

DISCIPLINE: CATEGORY: SUB CATEGORY: SHEET
C2-2