

I hereby certify that the portion of this technical information reproduced herein was prepared by me or under my direct supervision and that I am a duly registered Professional Engineer in the State of Minnesota.

ROBERT J. DAVIS, Reg. No. 12427

Signature: _____
 Date: _____

DESIGN
 ROBERT J. DAVIS, P.E.
 ARCHITECT, ENGINEER
 808 N. Hennepin Ave. Suite 100
 Minneapolis, MN 55412
 (612) 338-1111 FAX (612) 338-1112

VERIZON WIRELESS

PROJECT
 2007282841

 

MINC
 KILT

750 SNELLING AVENUE S
 ST. PAUL, MN 55116

SHEET CONTENTS:
 SITE PLAN

DRAWN BY:	BMS
DATE:	05-15-08
CHECKED BY:	BMS
REV. A:	07-08-08
REV. B:	08-13-08
REV. C:	07-24-11
REV. D:	08-23-11
REV. E:	04-10-12

A-1

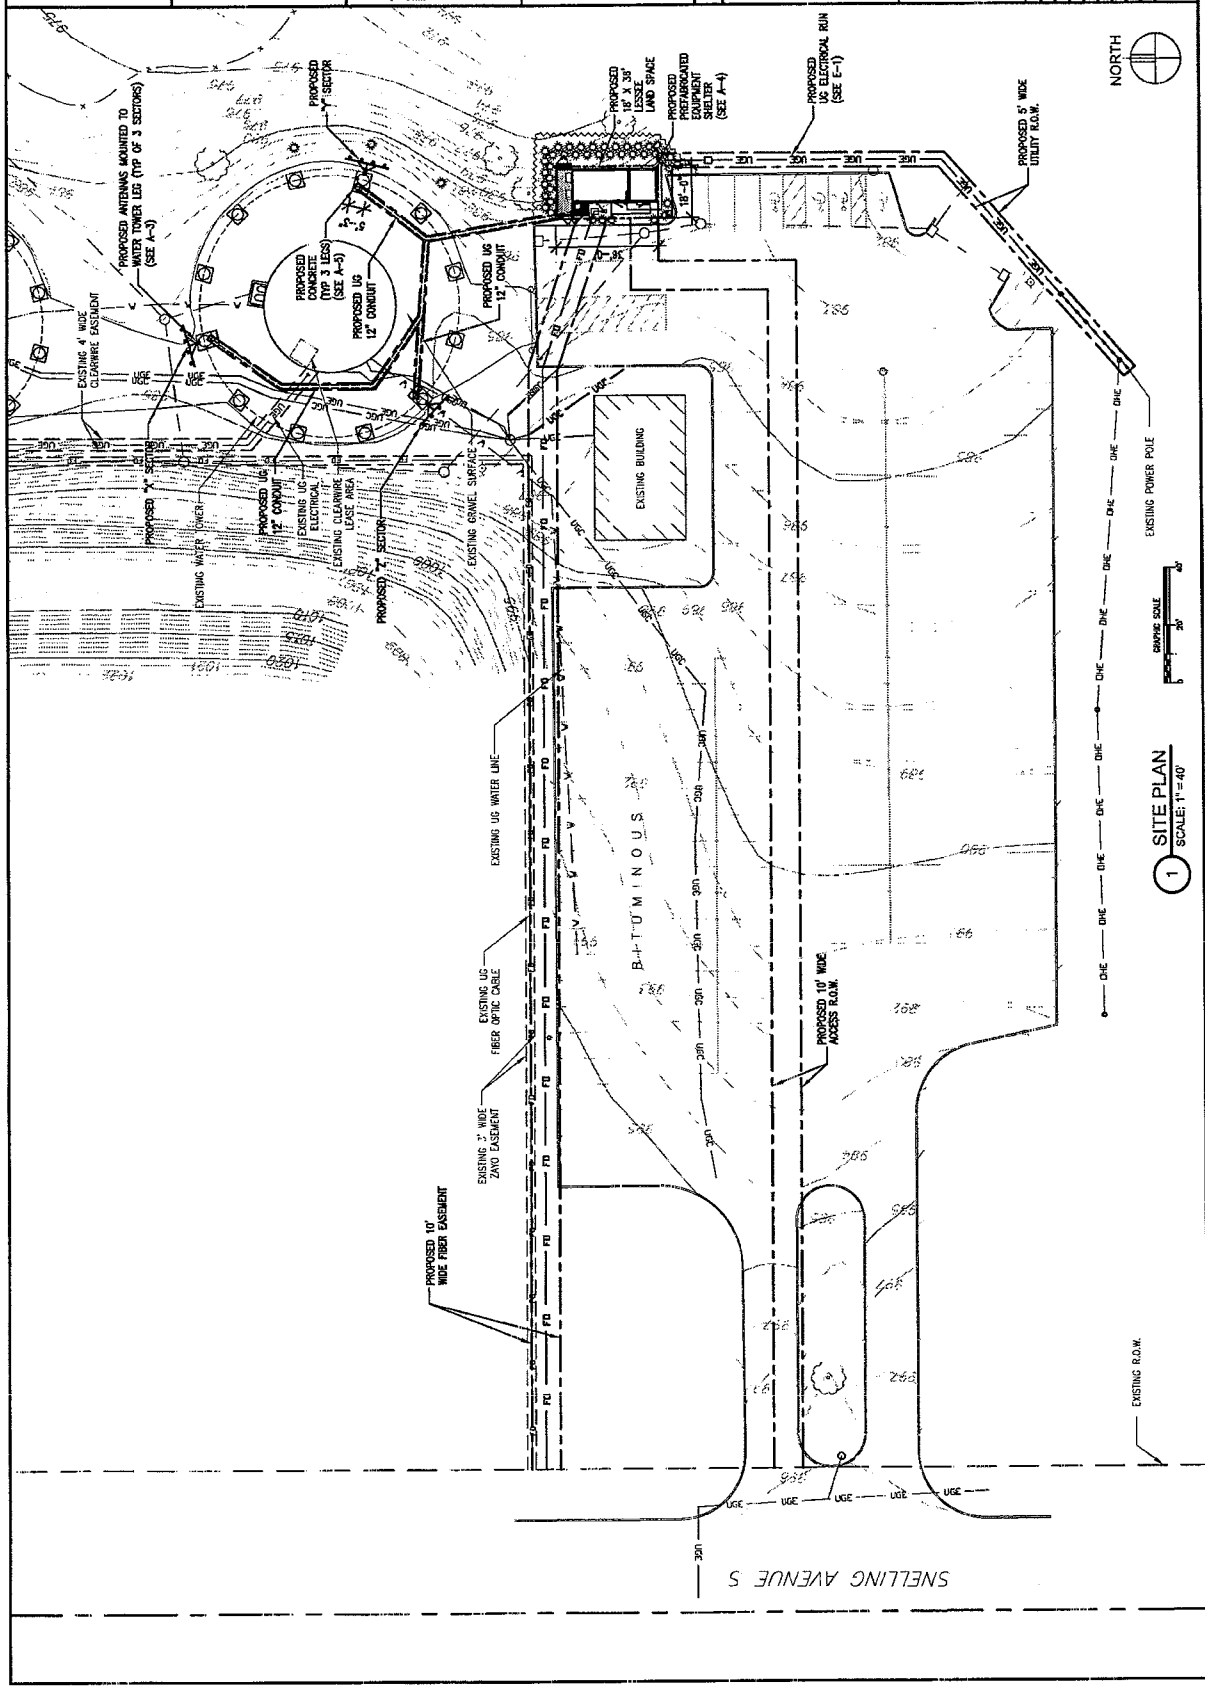

1 SITE PLAN
 SCALE: 1" = 40'