

WARNING:

THE CONTRACTOR SHALL BE RESPONSIBLE FOR CALLING FOR LOCATIONS OF ALL EXISTING UTILITIES. THEY SHALL COOPERATE WITH ALL UTILITY COMPANIES IN MAINTAINING THEIR SERVICE AND/OR RELOCATION OF LINES.

THE CONTRACTOR SHALL CONTACT GOPHER STATE ONE CALL AT 651-454-0002 AT LEAST 48 HOURS IN ADVANCE FOR THE LOCATIONS OF ALL UNDERGROUND WIRES, CABLES, CONDUITS, PIPES, MANHOLES, VALVES OR OTHER BURIED STRUCTURES BEFORE DIGGING. THE CONTRACTOR SHALL REPAIR OR REPLACE THE ABOVE WHEN DAMAGED DURING CONSTRUCTION AT NO COST TO THE OWNER.

USE

ee

ve.

ds

?

Snelling Ave.

Pascal St. N.

St. Anthony Ave.

(Trunk Highway No. 36)

MAJOR LEAGUE SOCCER STADIUM

233.9 - CONCOURSE

215.07 - PITCH

215.9 - SERVICE LEVEL

218.9/214.9 - LOADING DOCK

St. Anthony Ave.

(Trunk Highway No. 36)

MAJOR LEAGUE SOCCER STADIUM

233.9 - CONCOURSE

215.07 - PITCH

215.9 - SERVICE LEVEL

218.9/214.9 - LOADING DOCK

St. Anthony Ave.

(Trunk Highway No. 36)

MAJOR LEAGUE SOCCER STADIUM

233.9 - CONCOURSE




215.07 - PITCH

215.9 - SERVICE LEVEL

218.9/214.9 - LOADING DOCK

St. Anthony Ave.

(Trunk Highway No. 36)

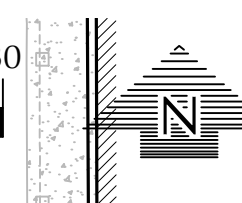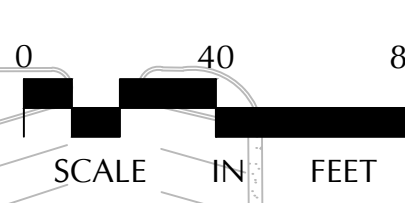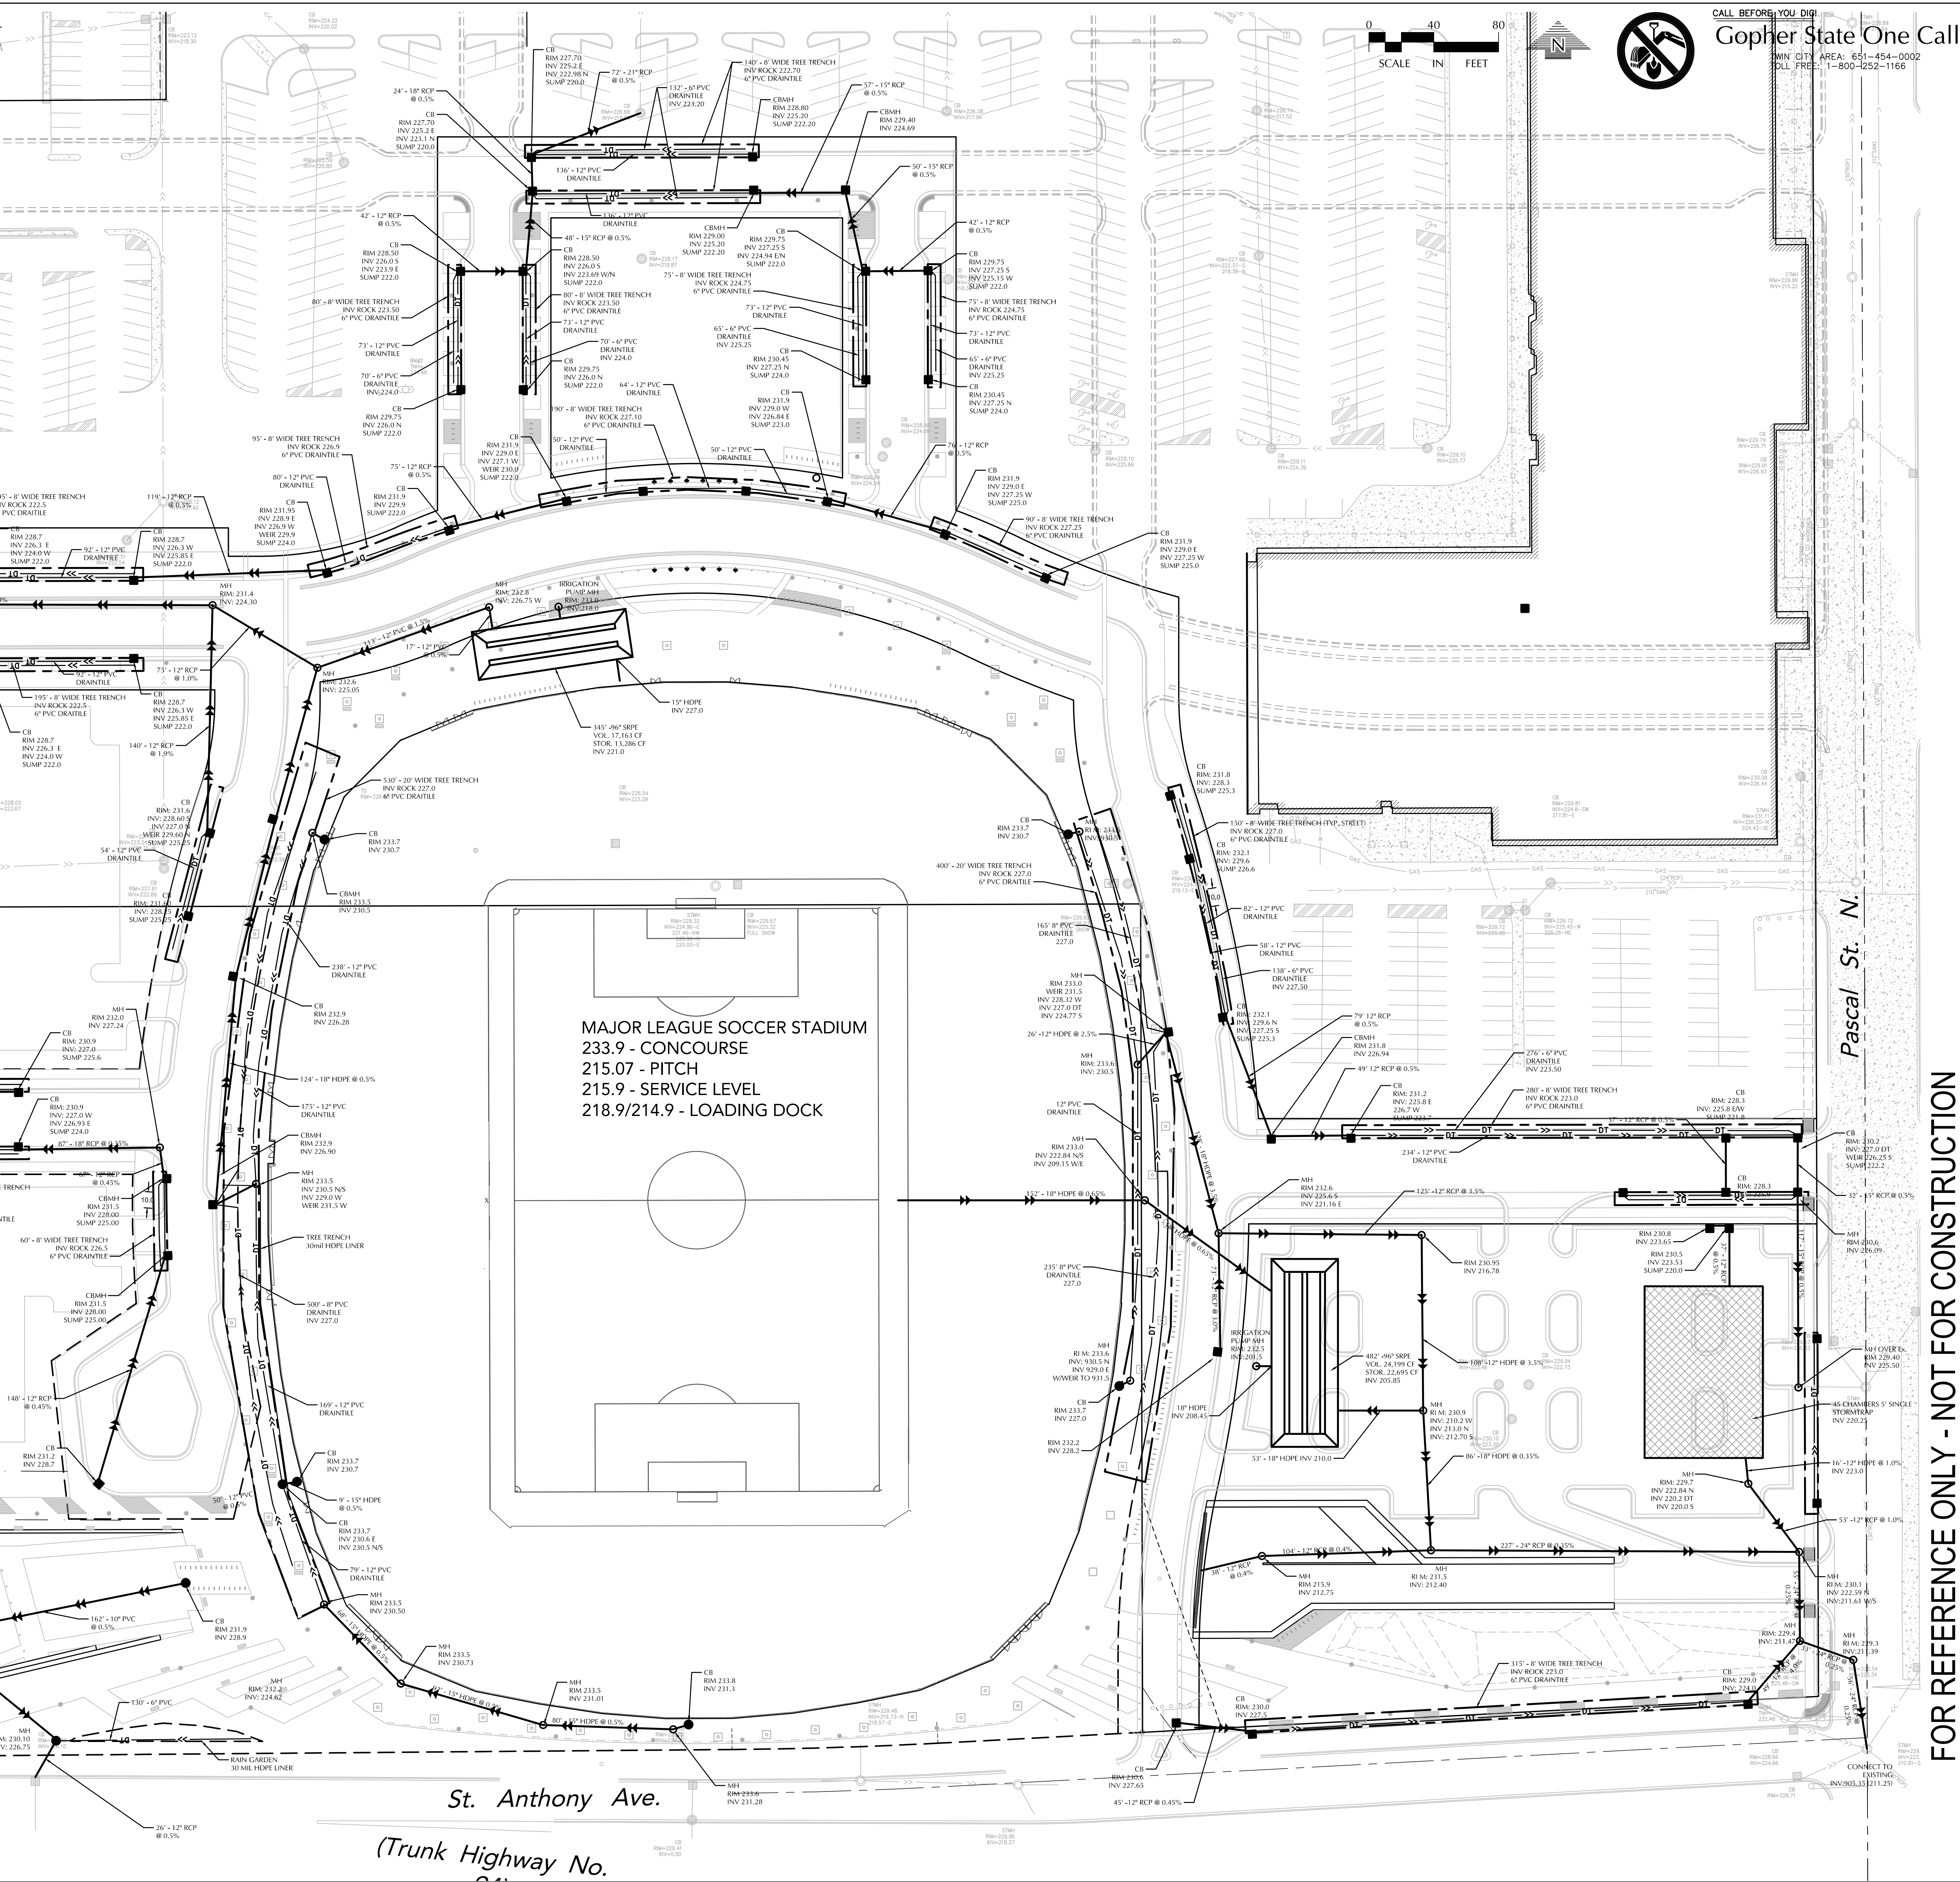

CALL BEFORE YOU DIG
Gopher State One Call
MINN CITY AREA: 651-454-0002
TOLL FREE: 1-800-252-1166

POPULOUS
Architecture, Planning,
Interior Programming,
4800 Main Street, Suite 300
Kansas City, Missouri 64112
816-234-1550

STRUCTURAL ENGINEER
WALTER P. MOORE
320 MAIN STREET, TENTH FLOOR
KANSAS CITY, MO 64105
816-701-2100

ME/P/E ENGINEER
ME ENGINEERS
10055 W 43RD AVENUE
WHEAT RIDGE, COLORADO 80033
303-421-6655

AUDIOVISUAL
WJWW INC.
4801 SPRING VALLEY RD. STE #113
DALLAS, TX 75244
972-966-7300

CIVIL ENGINEER
LOUCKS, INC.
7200 HEMLOCK LANE, SUITE 300
MINNETONKA, MN 55369
763-424-5555

LIFE SAFETY
HOWE ENGINEERS, INC.
101 LONGWATER CIRCLE, SUITE 203
NORWELL, MA 01961
781-878-3500

FOOD SERVICE
S22 CONSULTANTS, INC.
13 WINDING BRANCH RD.
HAWTHORN WOODS, IL 60047
224-717-1555

LOUCKS
PLANNING
CIVIL ENGINEERING
LAND SURVEYING
LANDSCAPE ARCHITECTURE
ENVIRONMENTAL

7200 Hemlock Lane, Suite 300
Minnetonka, MN 55369
763.424.5555
www.loucksinc.com

MINNESOTA MLS STADIUM
SAINT PAUL, MINNESOTA

RECONCILED SCHEMATIC DESIGN
JULY 22, 2016

REVISIONS		
NO.	DATE	DESCRIPTION
1	7-1-16	PRELIMINARY CITY SUBMITTAL
2	7-22-16	RECONCILED SCHEMATIC DESIGN

I hereby certify that this plan, specification or report was prepared by me or under my direct supervision and that I am a duly Licensed Professional Engineer under the laws of the State of Minnesota.

Jeffrey A. Shupek - PE
License No. 19624
Date 07-22-16

Project No. 16028A
Project Lead IAS
Drawn By TRG
Checked By IAS
Review Date 07-22-16

PROJECT NO. 16028A
DATE 07/22/16
SHEET TITLE OVERALL UTILITY PLAN
DISCIPLINE CATEGORY SUB CATEGORY SHEET C4-2A

LOUCKS, INC.

FOR REFERENCE ONLY - NOT FOR CONSTRUCTION