
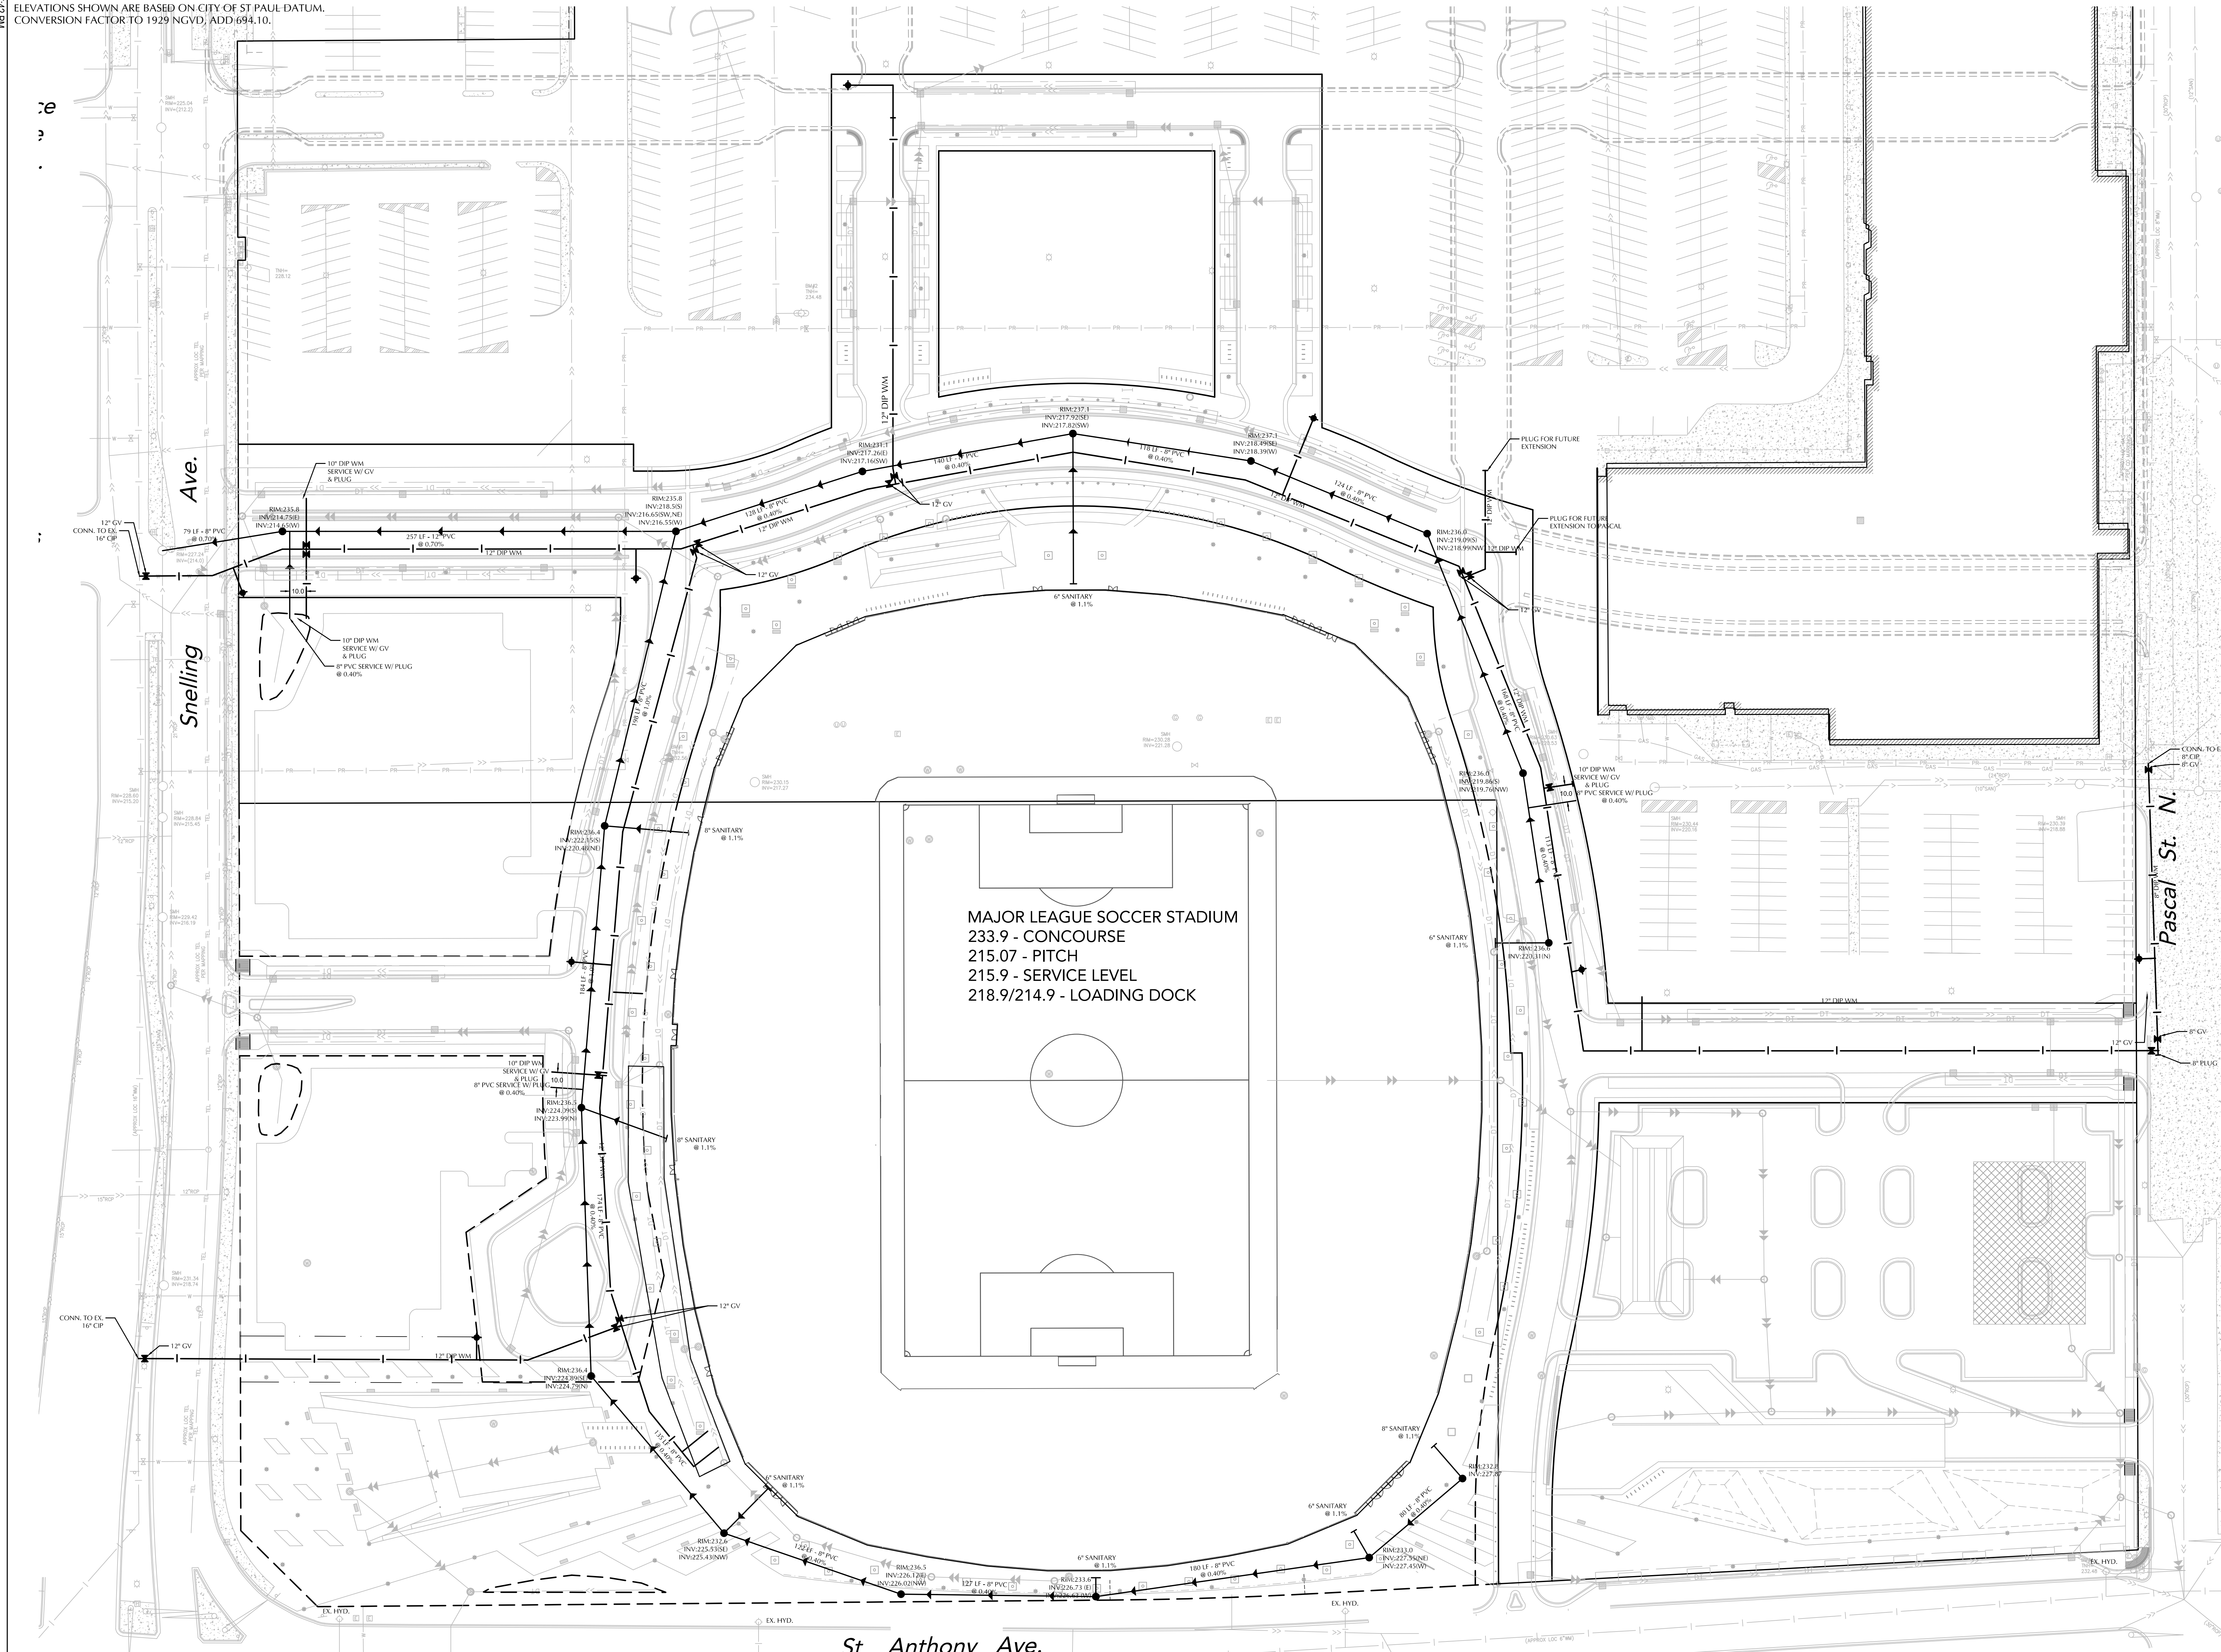


RUC 749-ZFP 01.02.2016

BENCHMARK
 TOP NUT OF FIRE HYDRANT 370 FEET SOUTH OF THE INTERSECTION OF UNIVERSITY AVENUE AND SNELLING AVENUE ON THE EAST SIDE OF SNELLING
 TNH ELEVATION = 228.15
 ELEVATIONS SHOWN ARE BASED ON CITY OF ST. PAUL DATUM.
 CONVERSION FACTOR TO 1929 NGVD, ADD 694.10.

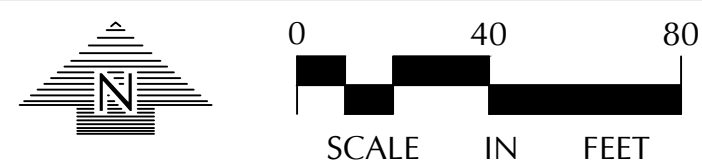

St. Anthony Ave.
 (Trunk Highway No. 63)

POPULOUS
 Architecture, Planning,
 Interior Programming
 4850 Main Street, Suite 300
 Kansas City, Missouri 64112
 816-221-1520

STRUCTURAL ENGINEER
 WALTER P. MOORE
 520 MAIN STREET, TENTH FLOOR
 KANSAS CITY, MO 64105
 816-761-2100

ME/P/PE ENGINEER
 ME ENGINEERS
 10055 W 43RD AVENUE
 WHEAT RIDGE, COLORADO 80033
 303-421-6555

AUDIOVISUAL
 W.I.W.W. INC.
 4801 SPRING VALLEY RD. STE #113
 DALLAS, TX 75244
 972-565-7320

CIVIL ENGINEER
 LOUCKS, INC.
 7200 HEMLOCK LANE, SUITE 300
 MAPLE GROVE, MN 55369
 763-424-5585

LIFE SAFETY
 HOWE ENGINEERS, INC.
 101 LONGWATER CIRCLE, SUITE 203
 NORWELL, MA 02061
 781-878-3500

FOOD SERVICE
 S20 CONSULTANTS, INC.
 13 WINDING BRANCH RD.
 HAWTHORN WOODS, IL 60047
 224-717-1555

LOUCKS
 PLANNING
 CIVIL ENGINEERING
 LAND SURVEYING
 LANDSCAPE ARCHITECTURE
 ENVIRONMENTAL

7200 Hemlock Lane, Suite 300
 Maple Grove, MN 55369
 763.424.5505
 www.loucksinc.com

MINNESOTA MLS SOCCER STADIUM

SAINT PAUL, MINNESOTA

FOR REFERENCE ONLY - NOT FOR CONSTRUCTION

SCHEMATIC DESIGN
 APRIL 15, 2016

REVISIONS

NO.	DATE	DESCRIPTION
1	7-1-16	PRELIMINARY CITY SUBMITTAL

Jeffrey A. Shopak - PE
 License No. 19624
 Date 07-01-16

Loecks Project No. 16028A
 Project Lead JAS
 Drawn By TRG
 Checked By JAS
 Review Date 07-01-16

PROJECT NO. 16028A
 SHEET DATE 07/01/16
 SHEET TITLE **OVERALL UTILITY PLAN SANITARY & WATERMAIN**
 DISCIPLINE CATEGORY SUB CATEGORY SHEET
C4-2

Copyright ©POPULOUS