



Constantly attended location


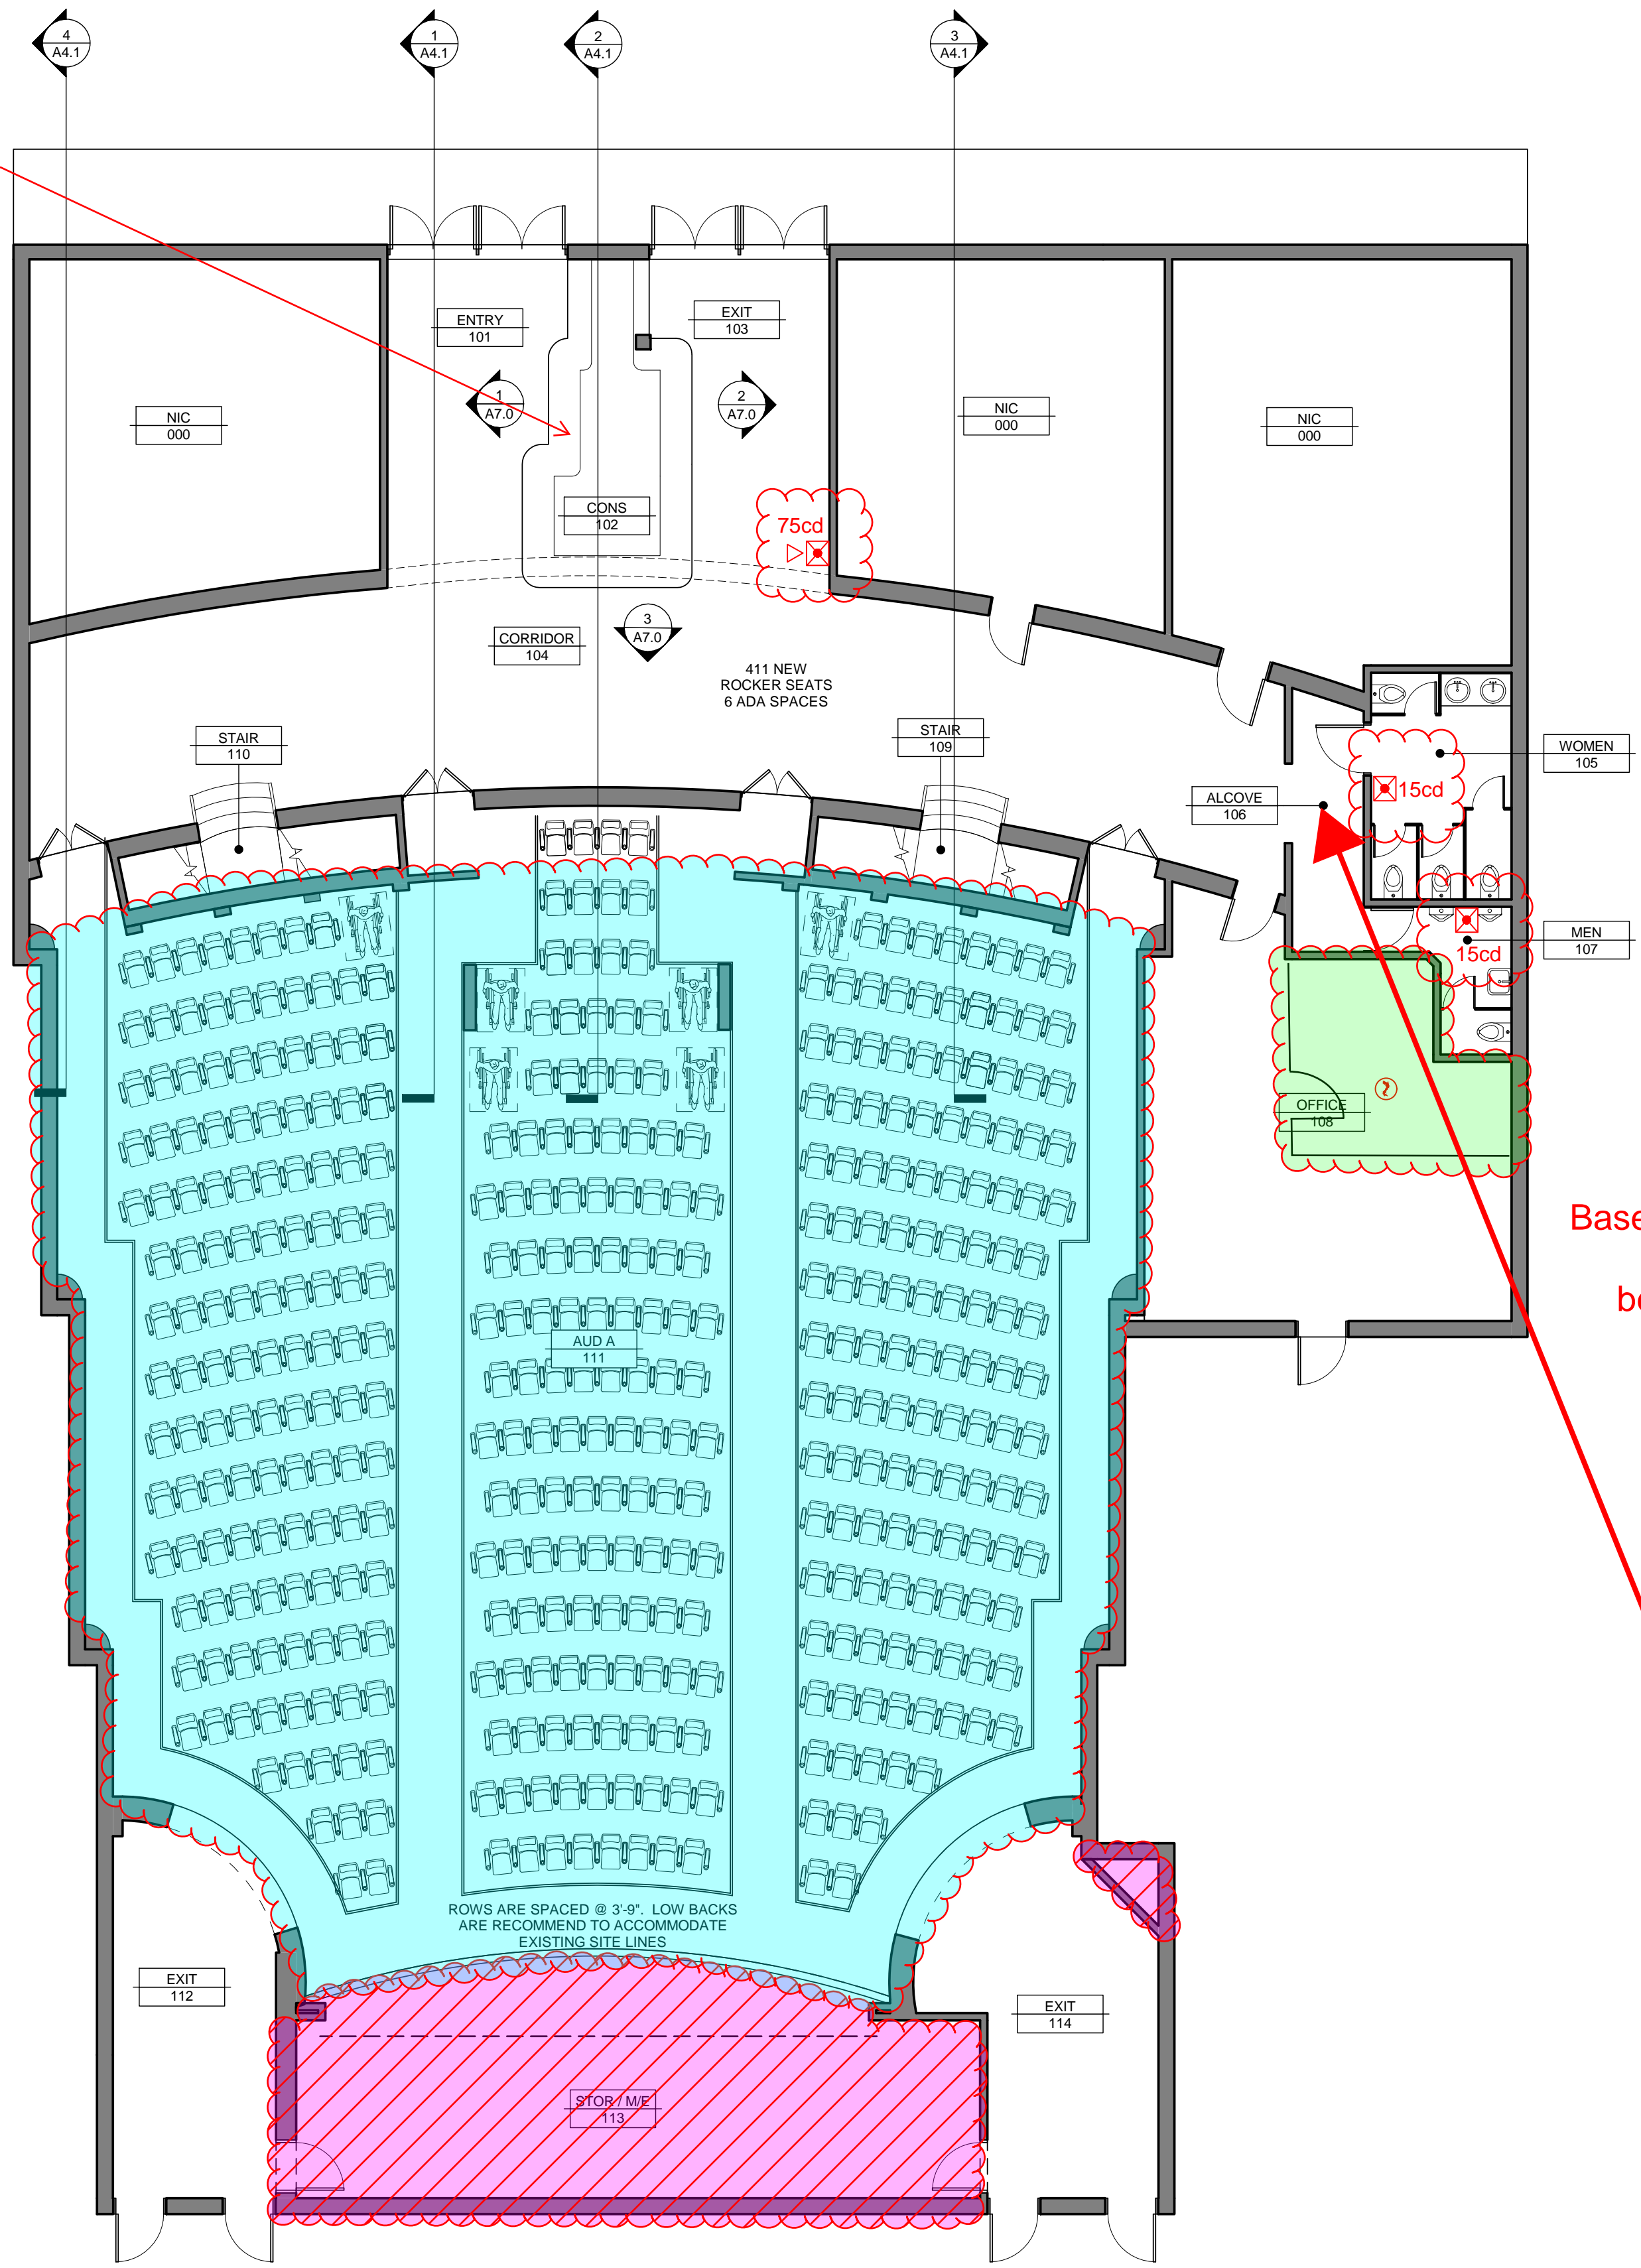


1 MAIN FLOOR PLAN  
A2.1 SCALE: 1/8" = 1'-0"

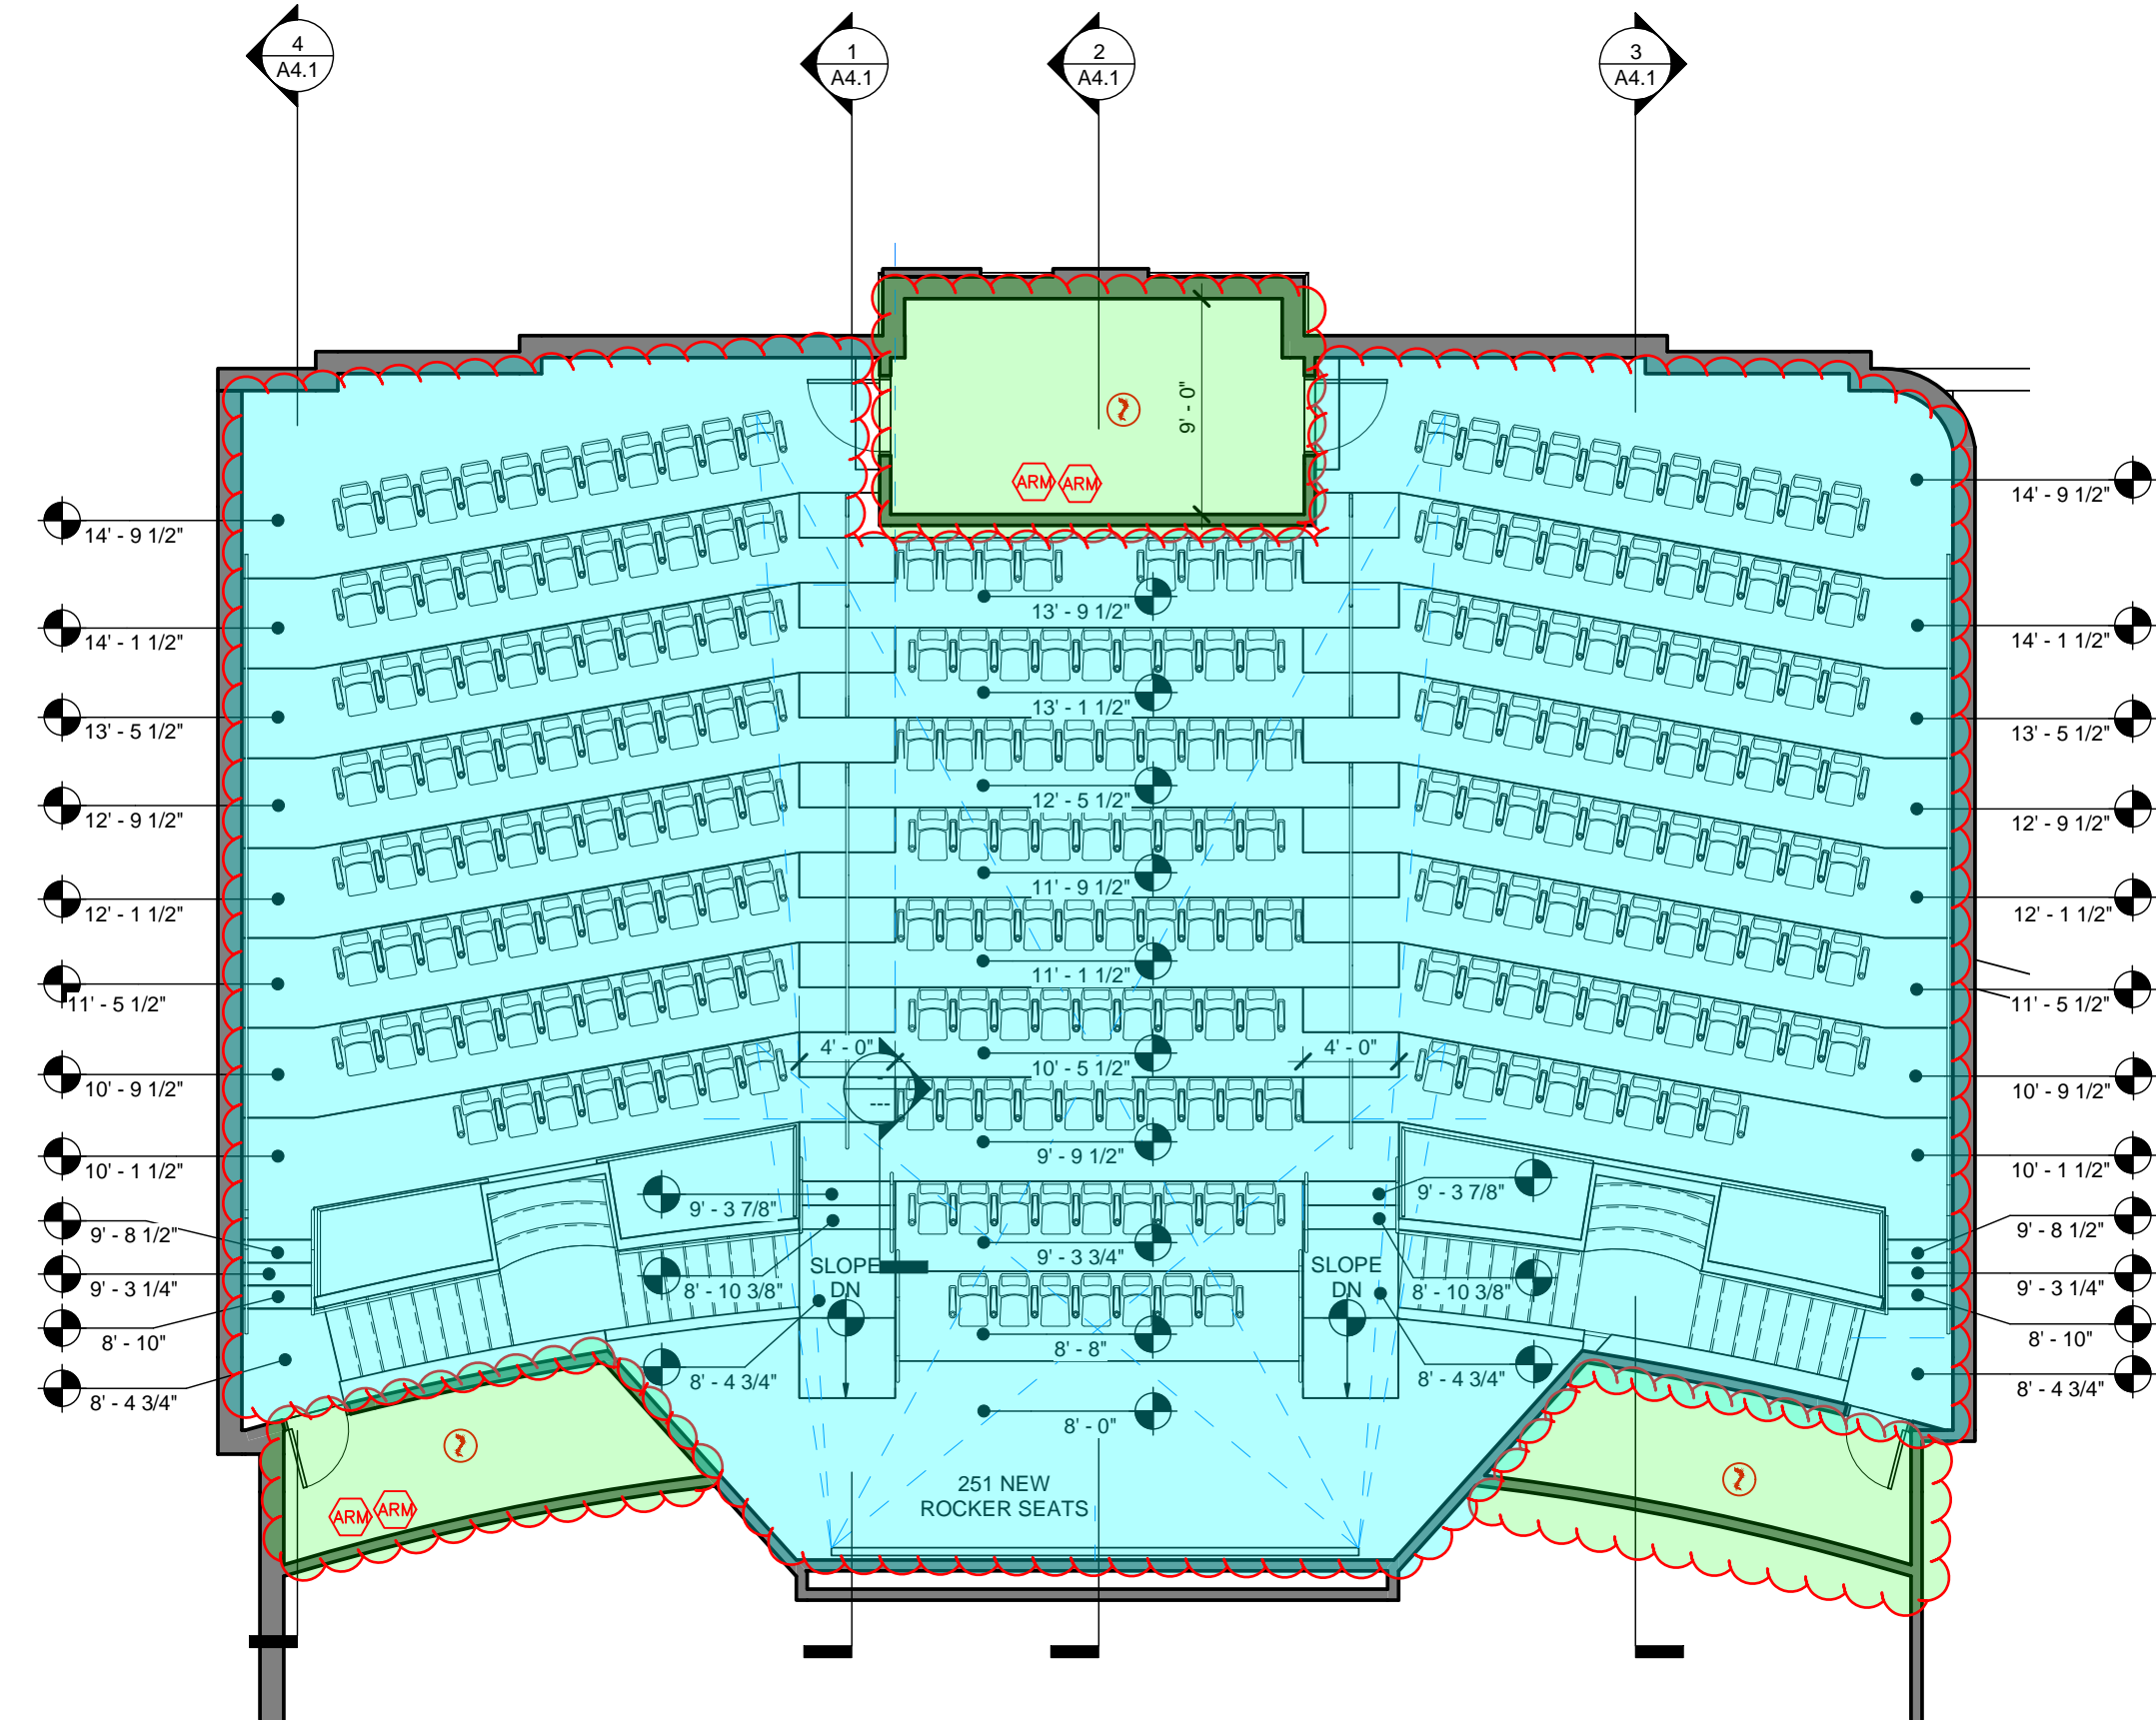

2 SECOND FLOOR PLAN  
A2.1 SCALE: 1/8" = 1'-0"

Basement storage area  
beneath this area

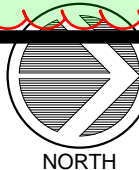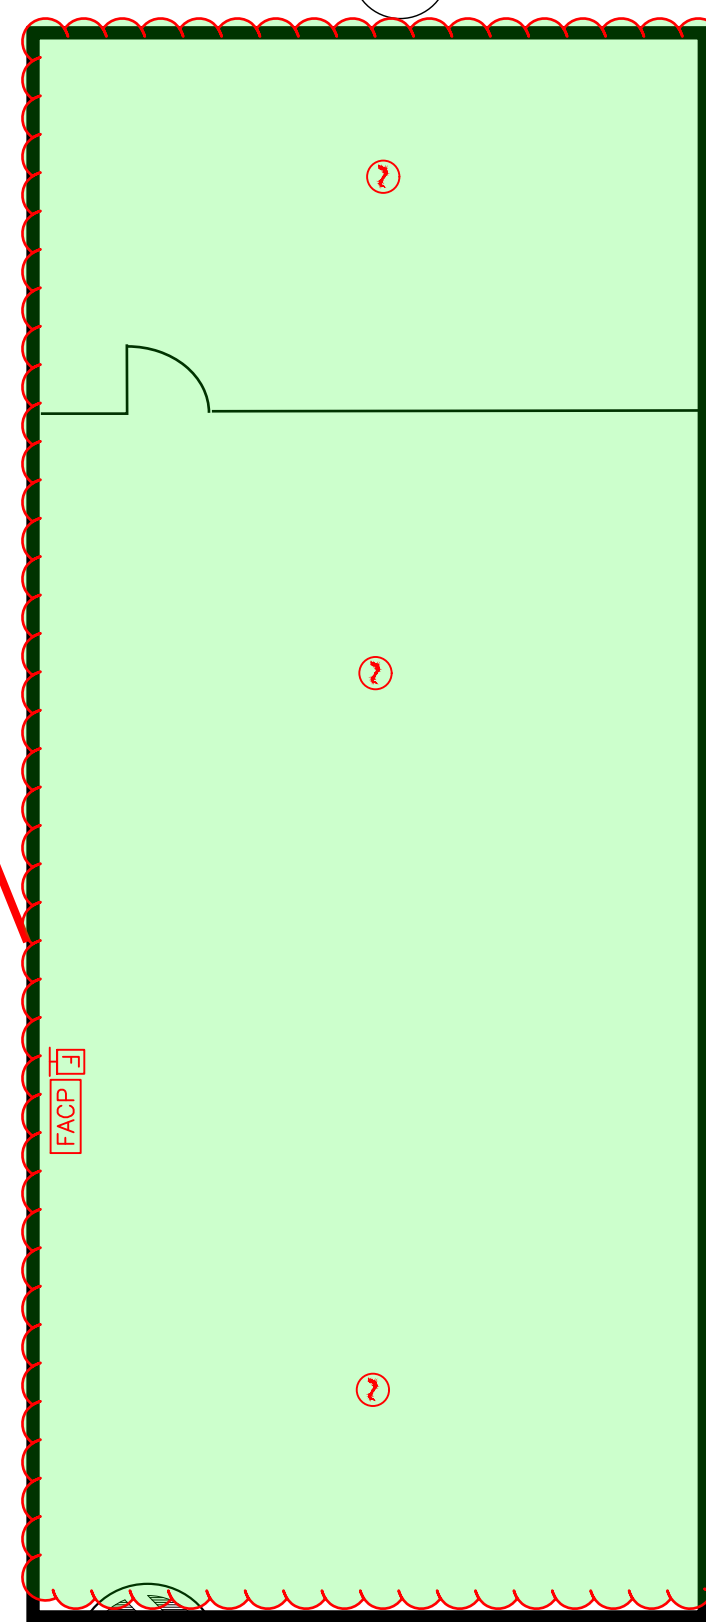


Legend			
Description	Quantity	Unit	
Addressable Relay Module	4	Count	
Cloud - Detection Required	5	Count	
Cloud - No Detection - FIRE SEPERATION REQUIRED	2	Count	
Cloud - Voice EVAC over existing system	2	Count	
Fire Alarm Control Panel	1	Count	
Horn/Strobe (wall)	1	Count	
Pull Station	1	Count	
Smoke Detector (ceiling)	7	Count	
Strobe (wall)	2	Count	


Mann  
Theaters  
Highland

St. Paul, MN



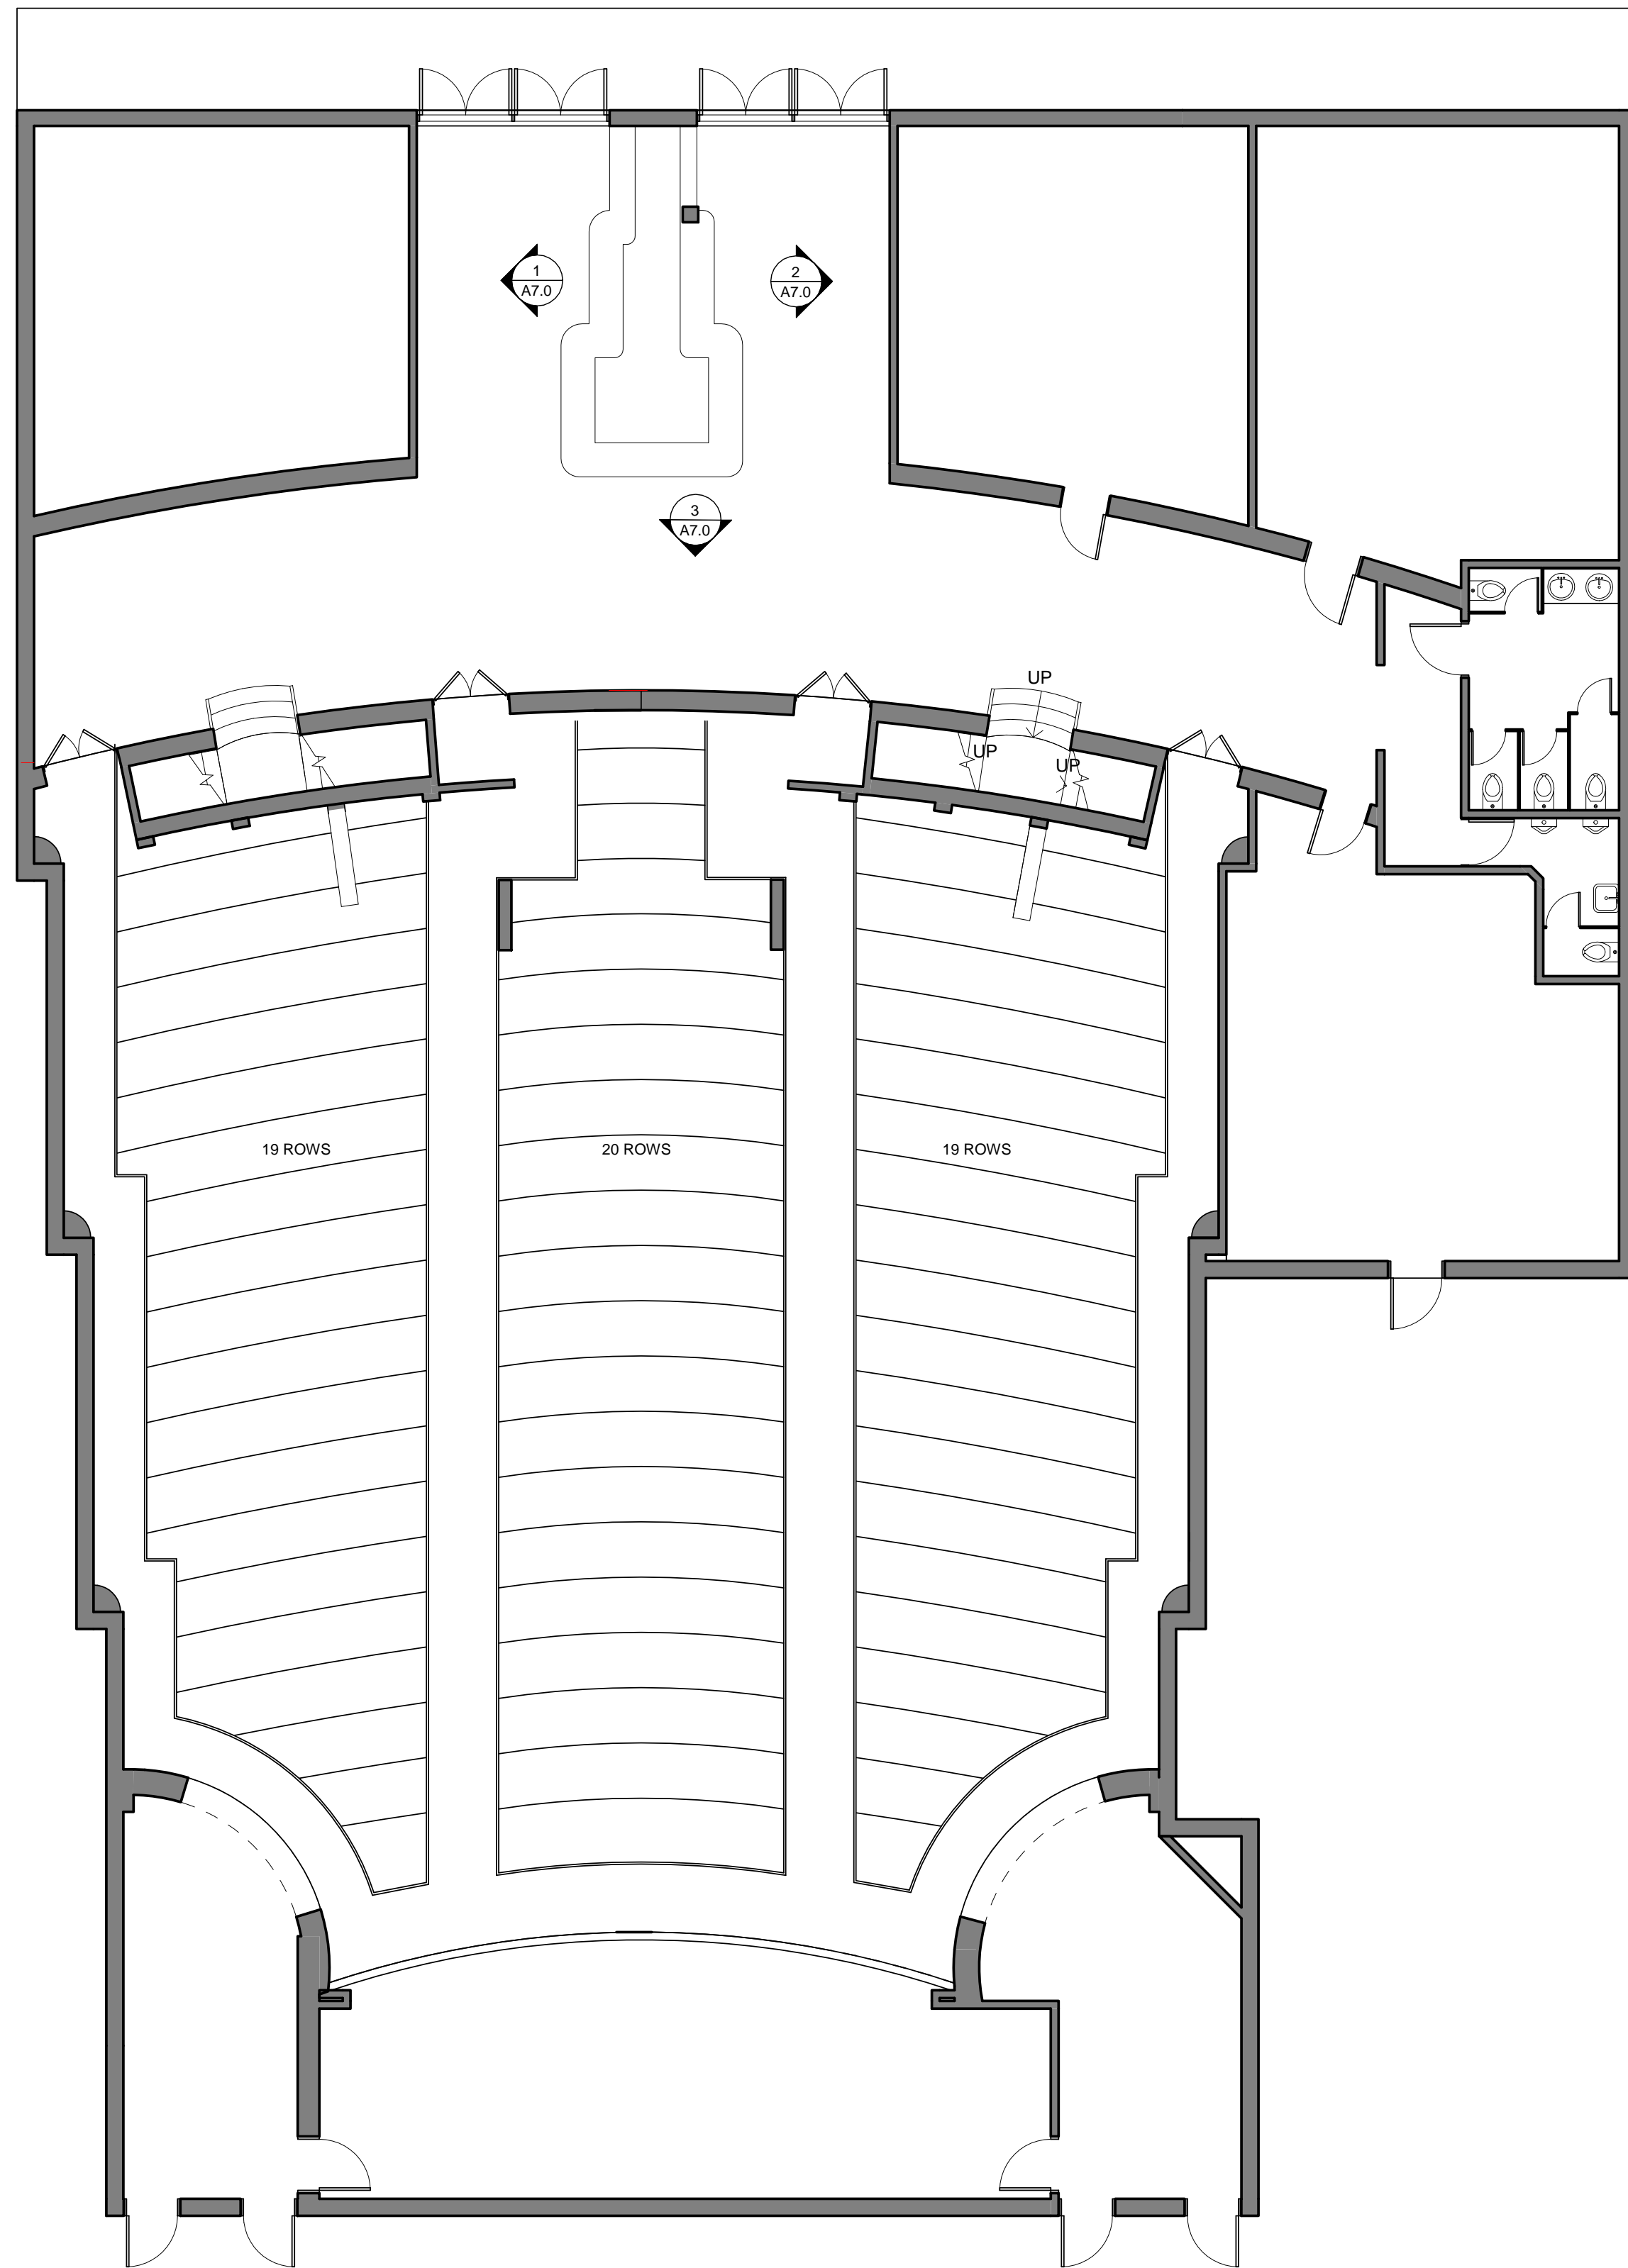

1 MAIN FLOOR DEMOLITION  
D1.1 SCALE: 1/8" = 1'-0"

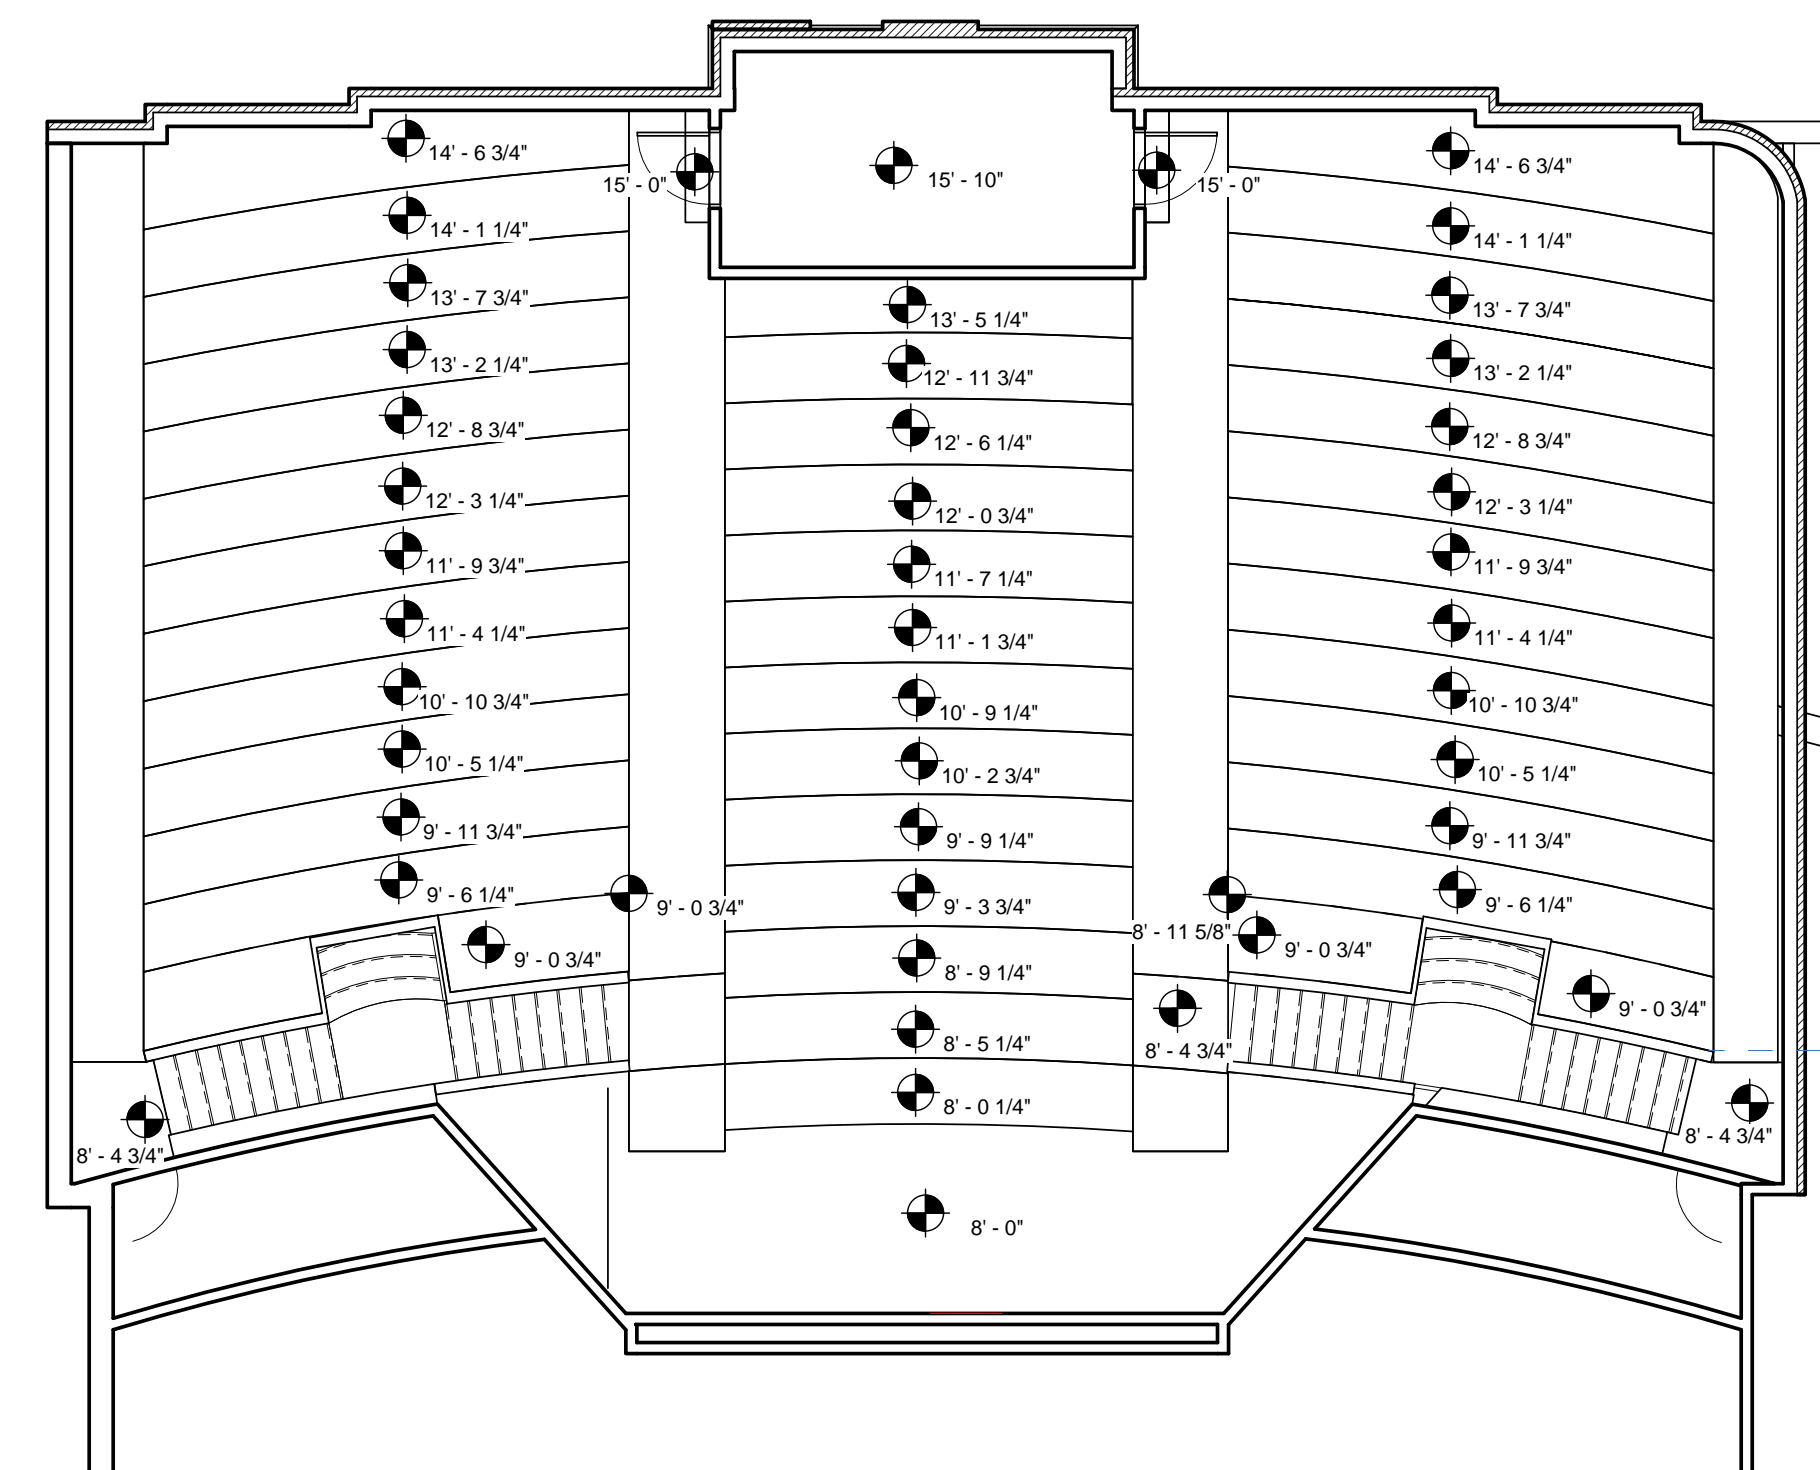

2 SECOND FLOOR DEMOLITION  
D1.1 SCALE: 1/8" = 1'-0"



Project Type:

Mann  
Theaters  
Highland

St. Paul, MN